

CONSULTANT:

SEAL:

CITY OF CARIBOU, MAINE
CARIBOU POLICE DEPARTMENT

PROJECT NUMBER: 23-199

SUBMISSION:
PROGRESS SET

ORIGINAL ISSUE DATE:
01/29/2025


SHEET REVISION SCHEDULE:
No. DATE

FIRST FLOOR PLAN

SHEET NUMBER:

A101

1/29/2025 3:45:23 PM

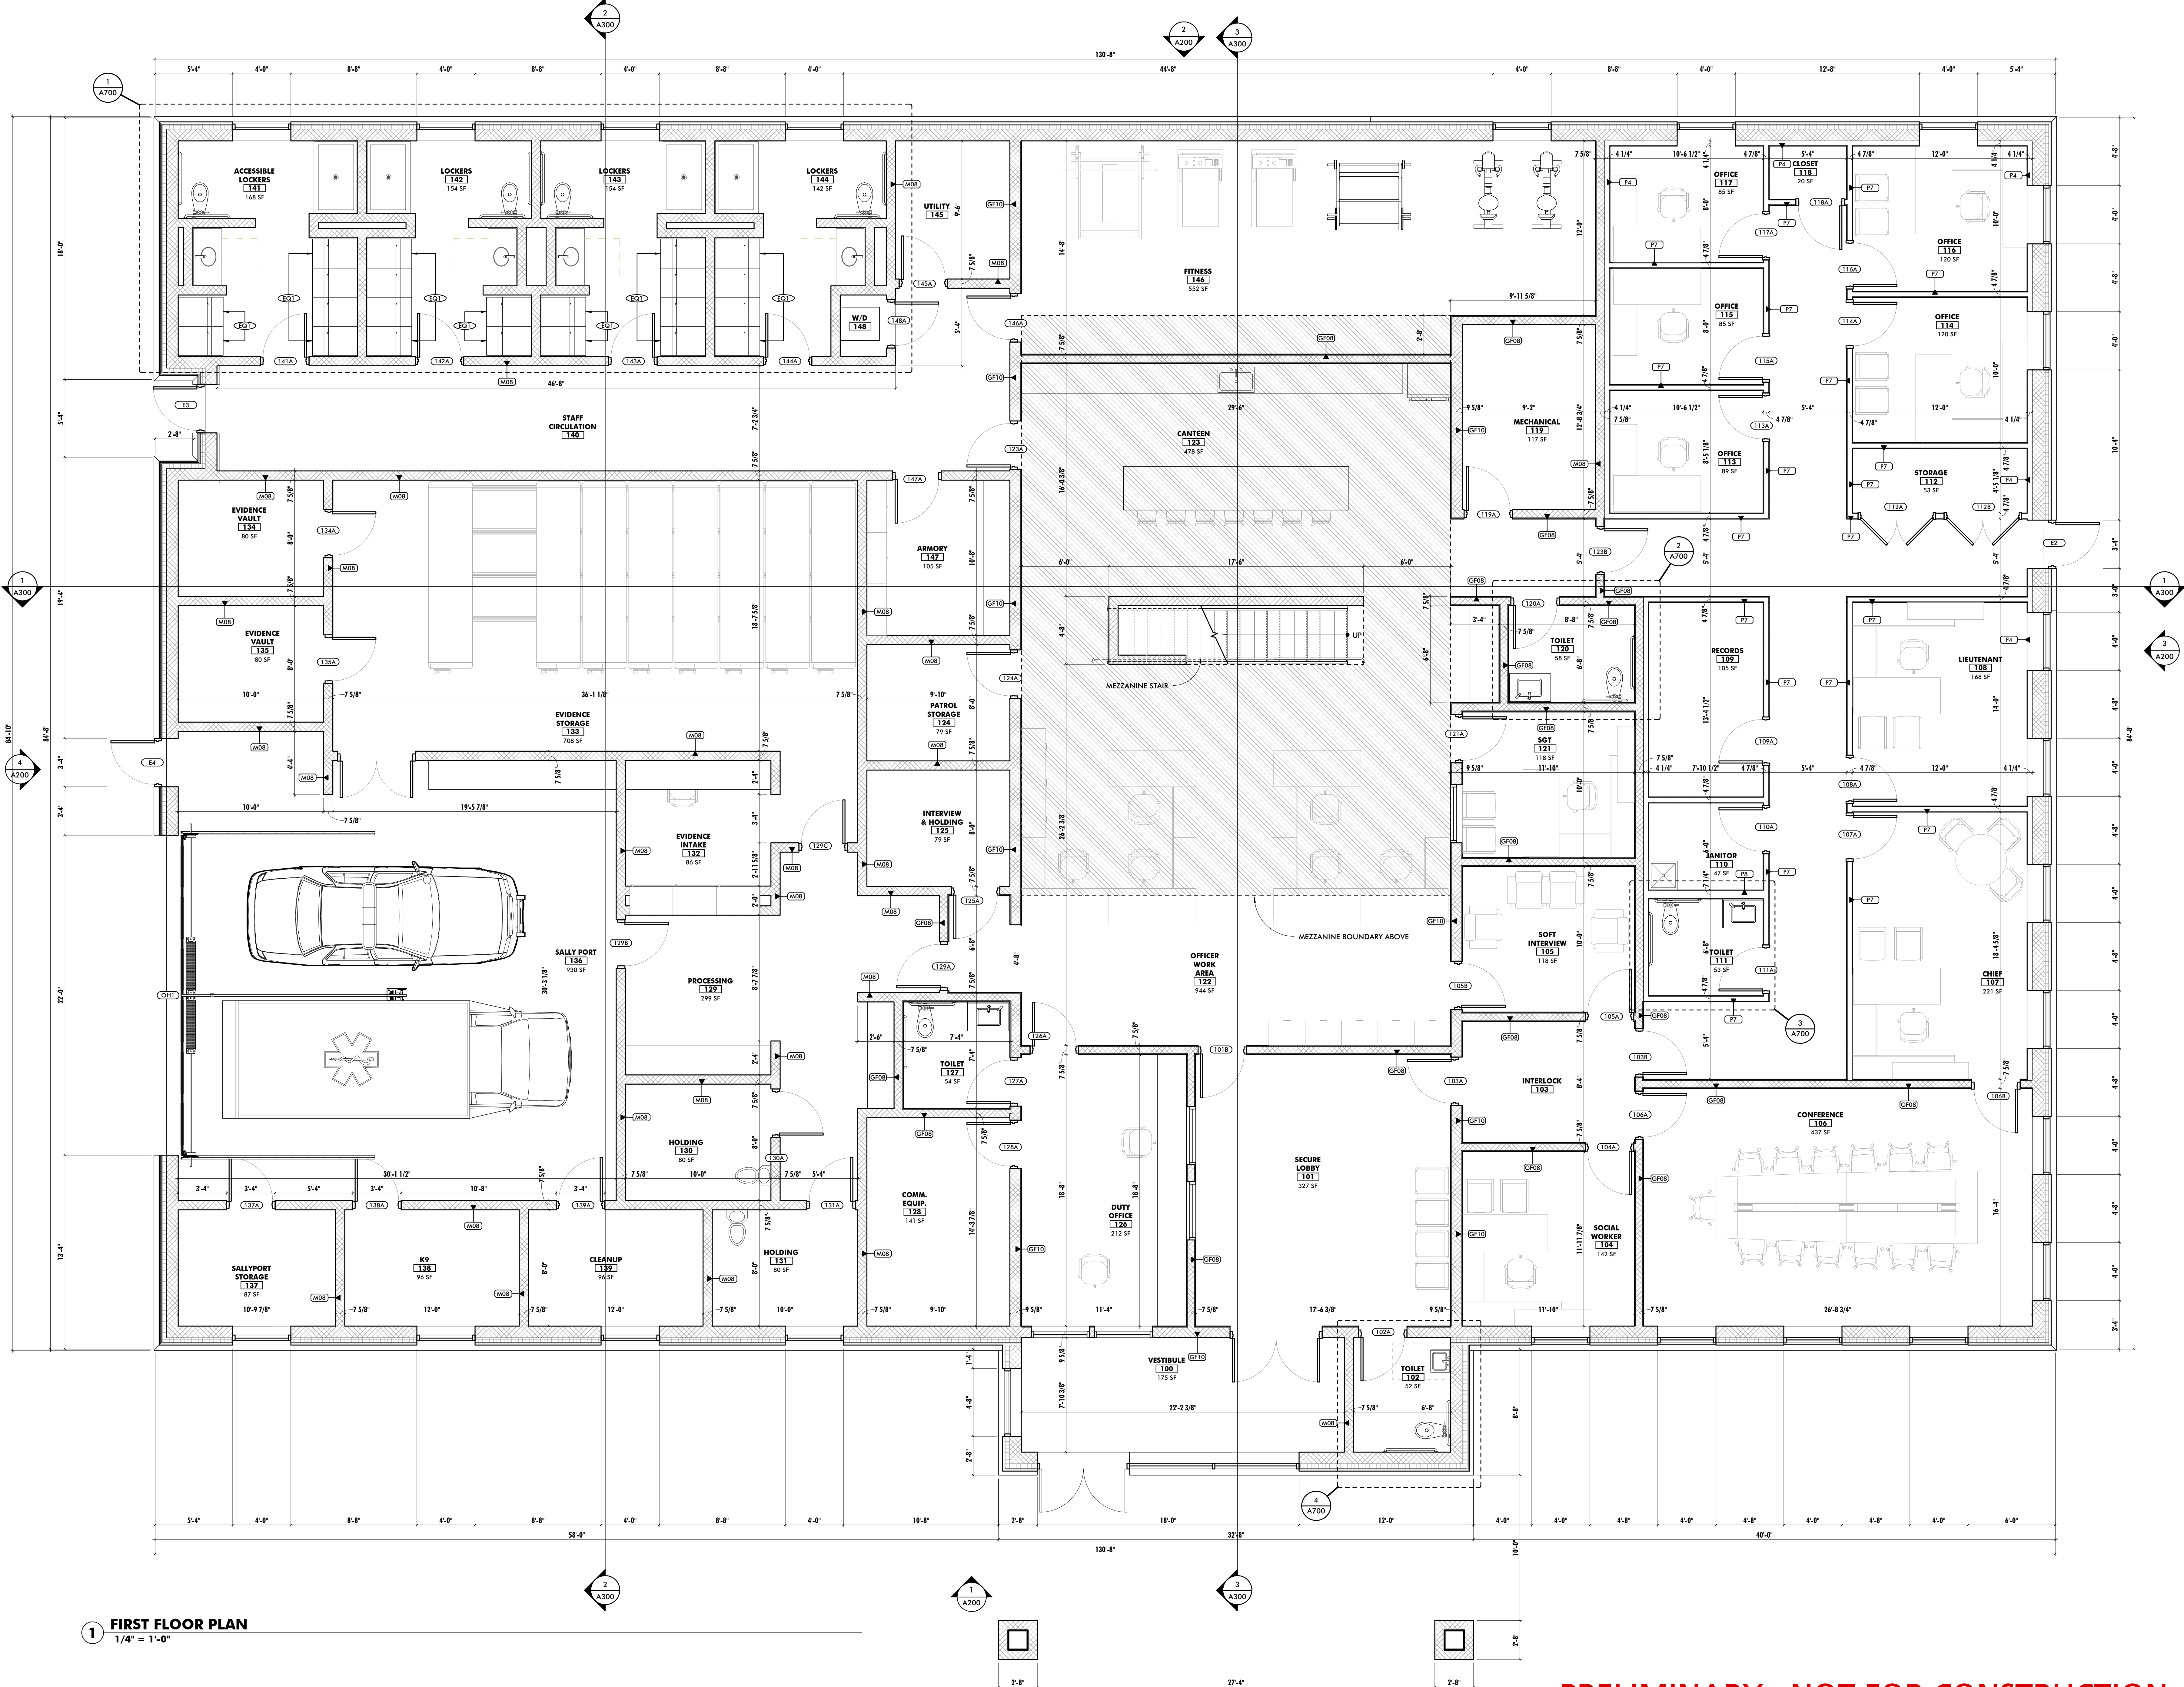

PRELIMINARY - NOT FOR CONSTRUCTION